


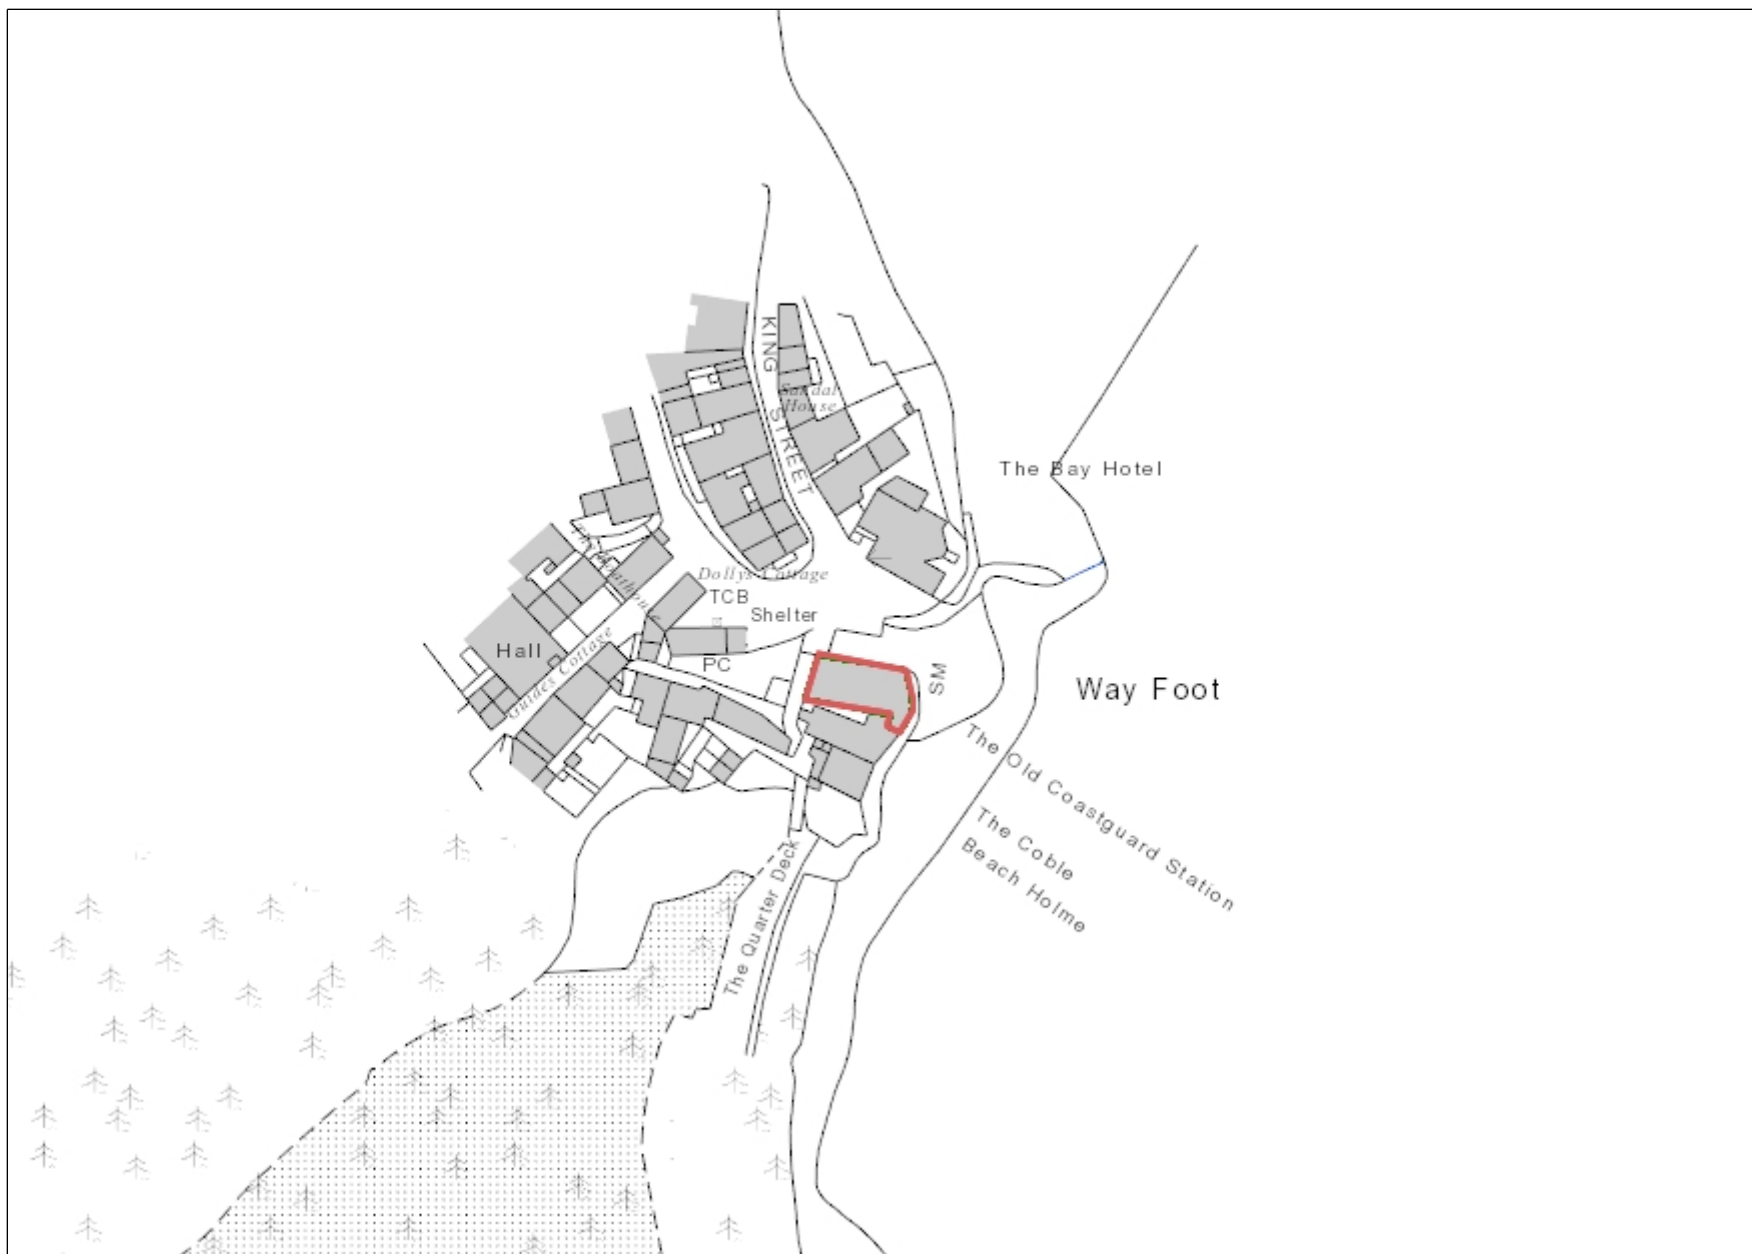

Robin Hood's Bay Old Coastguard Station - Location Plan



 
Legend

- NT Ownership (GB)
- NT Leasehold (GB)

NYMNPA

09/11/2020

1: 1,250



British_National_Grid
 © Crown copyright and database rights 2020 Ordnance Survey 100023974

This map is a user generated static output from an Intranet mapping site and is for reference only. Data layers that appear on this map may or may not be accurate, current, or otherwise reliable.


THIS MAP IS NOT TO BE USED FOR NAVIGATION

Notes

This map was automatically generated using the National Trust GIS Browser



Block plan of site 1 : 500

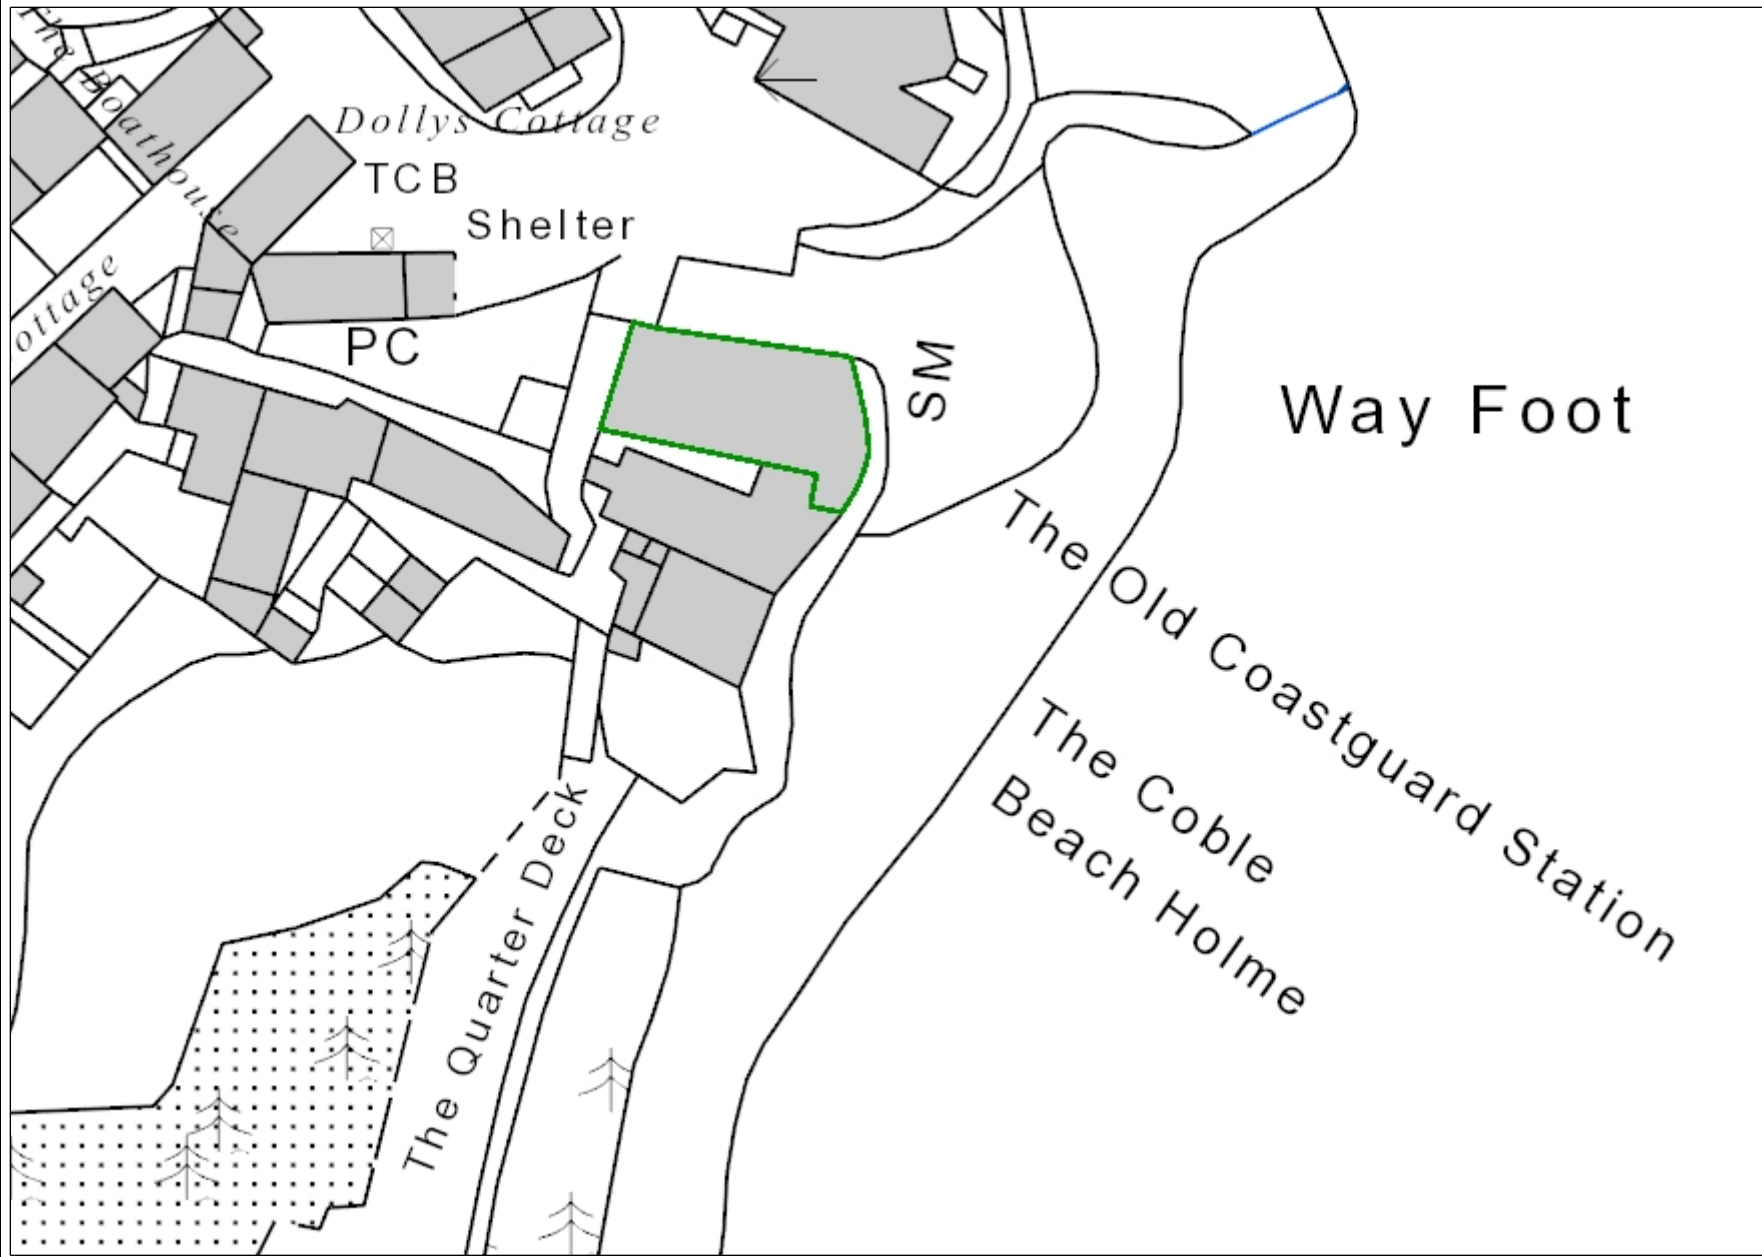

Legend

- NT Ownership (GB)
- NT Leasehold (GB)

NYMNPA

09/11/2020

1: 500



British_National_Grid
 © Crown copyright and database rights 2020 Ordnance Survey 100023974

This map is a user generated static output from an Intranet mapping site and is for reference only. Data layers that appear on this map may or may not be accurate, current, or otherwise reliable.

THIS MAP IS NOT TO BE USED FOR NAVIGATION


Notes

This map was automatically generated using the National Trust GIS Browser

NYMNPA

09/11/2020

NOTES
 Figured dimensions must be taken in preference to scaled dimensions. Contractors, sub-contractors and suppliers must verify all dimensions on site before commencing any work or making any shop drawings.
 This drawing to be read in conjunction with structural, mechanical and electrical drawings and other relevant information and any discrepancies are to be reported to the Architect. Work and materials to be in accordance with the Building Regulations and to comply with relevant British Standards.
 This drawing is the copyright of Allen Tod and should not be reproduced in whole or in part without their written permission.

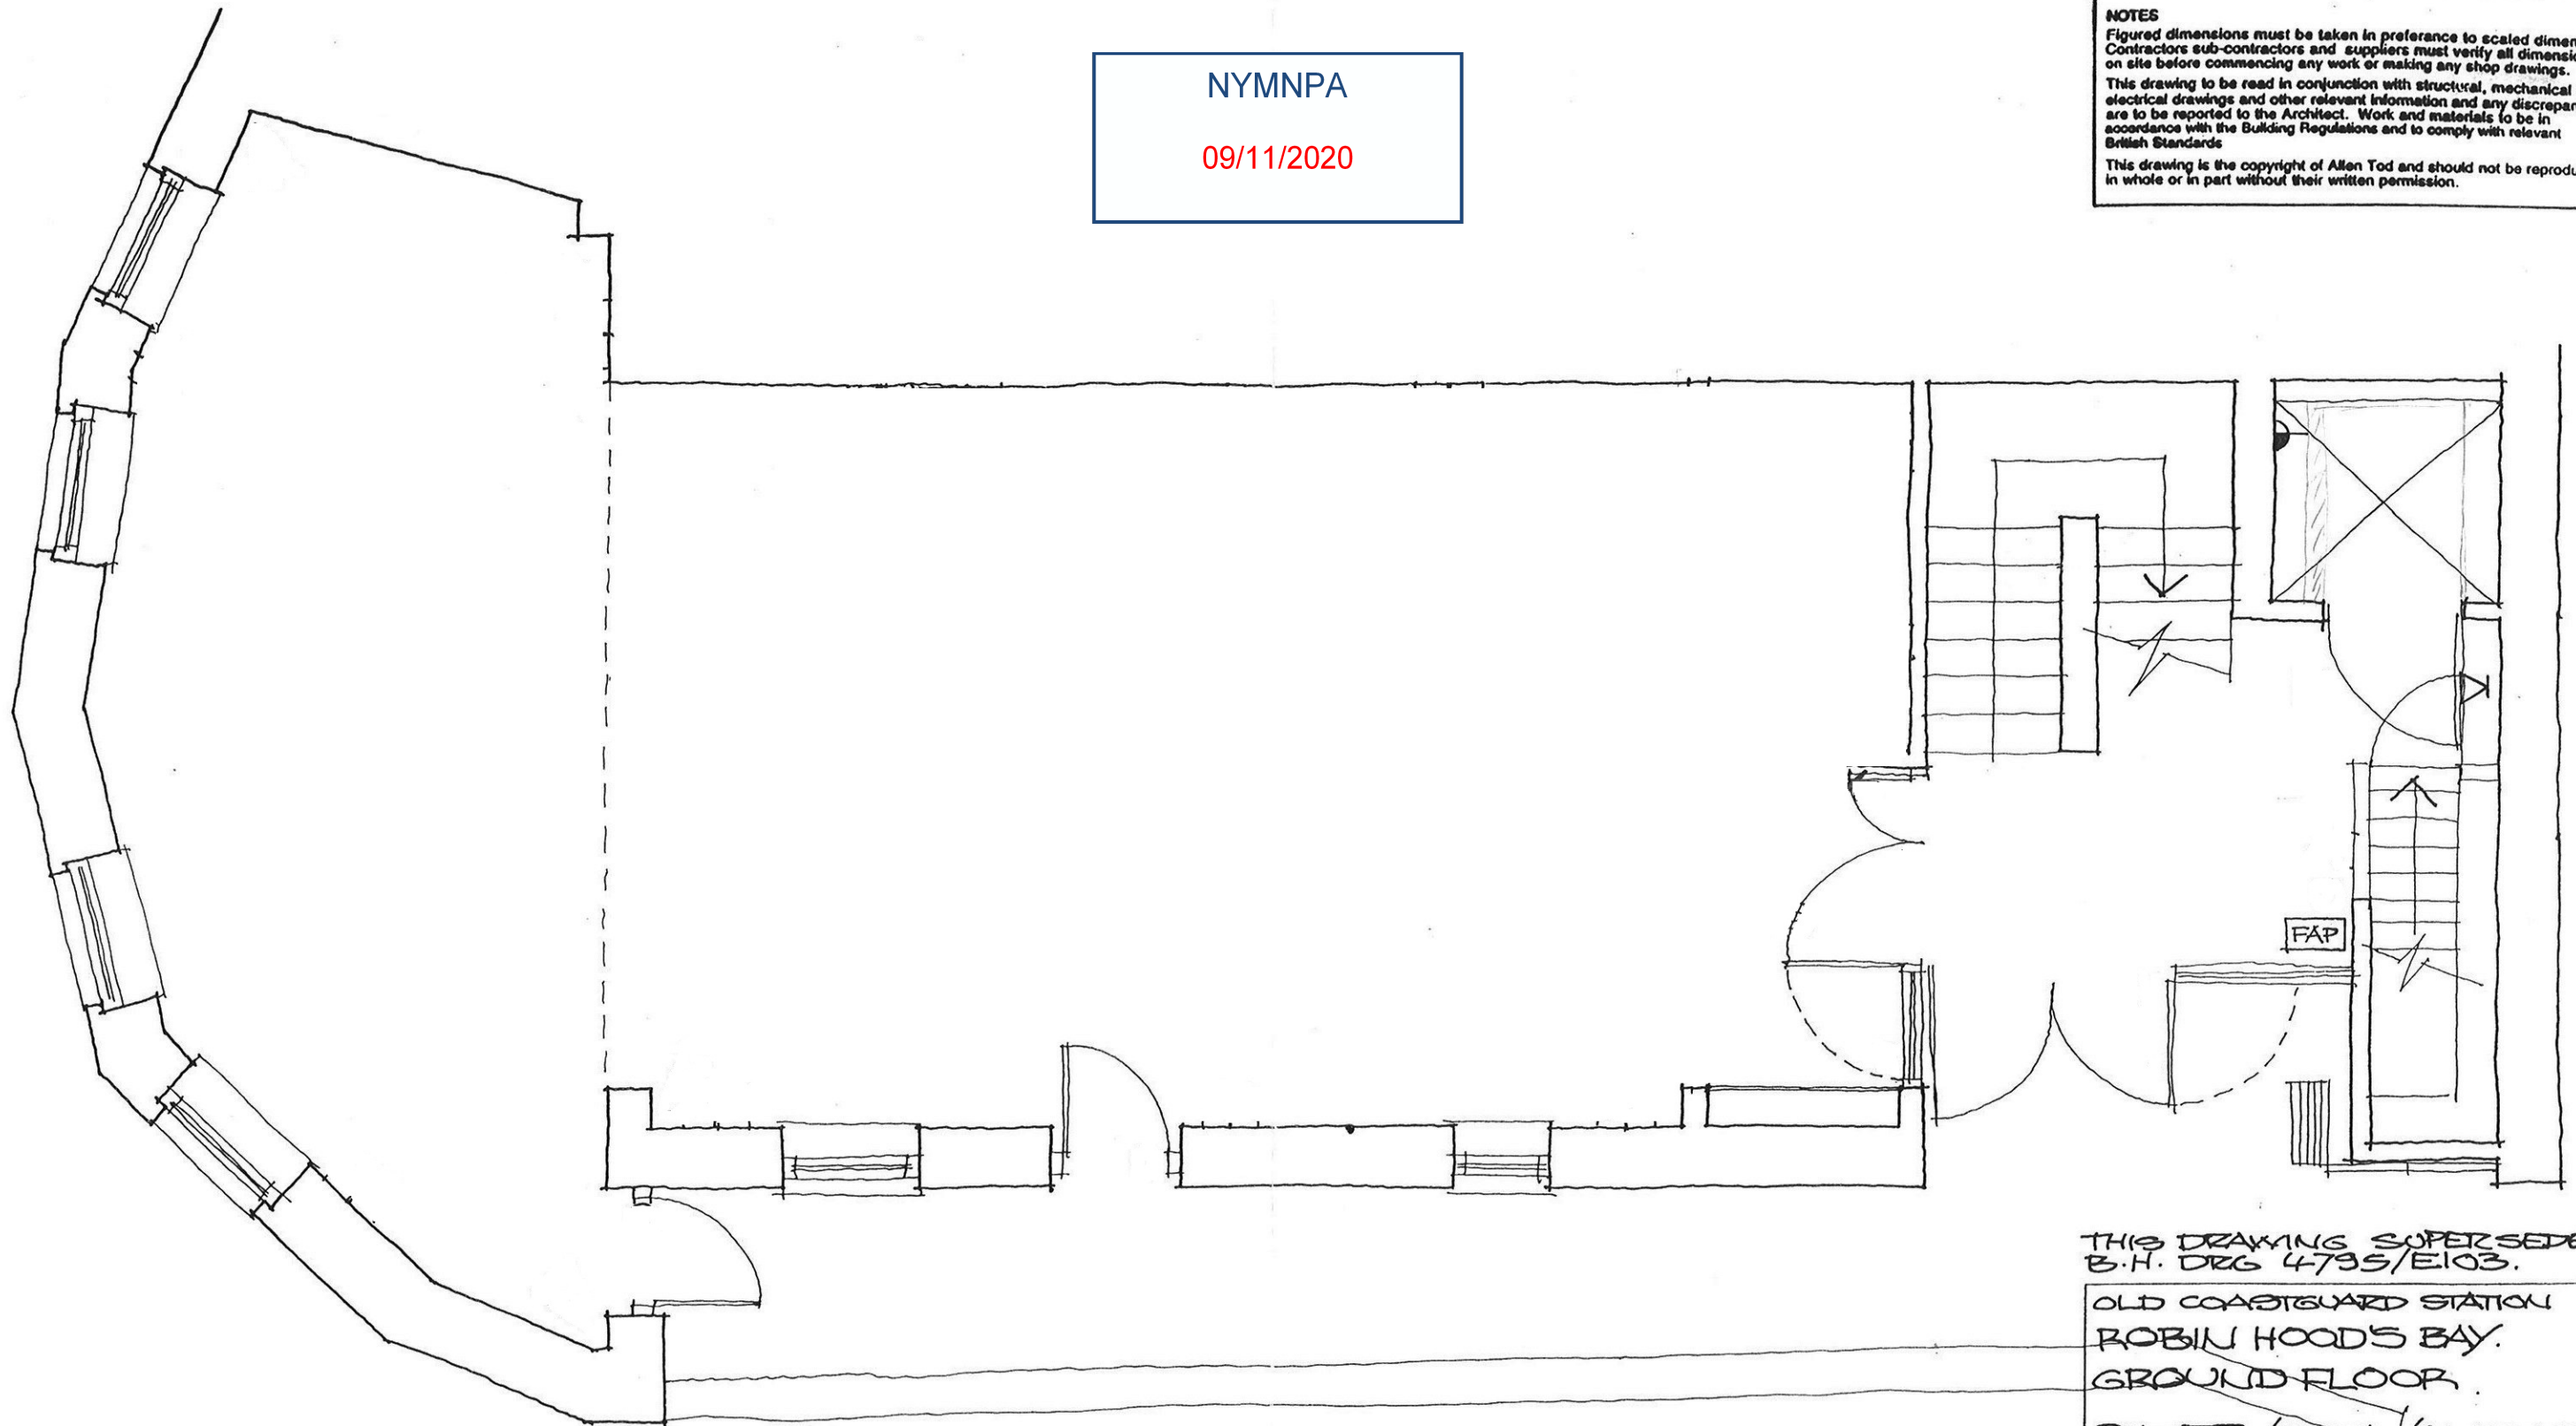

THIS DRAWING SUPERSEDES B.H. DRG 4795/E103.

OLD COASTGUARD STATION
 ROBIN HOOD'S BAY.
 GROUND FLOOR.
 POWER / DATA / ALARMS.

SEE BURS HAPPOLD SPECIFICATION AND DRAWING 4795/E001 FOR KEY.

- ⓔ FLOOR MOUNTED ELECTRO MAGNETIC DOOR HOLDER LINKED TO FIRE ALARM SYSTEM.
- Ⓢ AUDIO LOUDSPEAKERS WIRED TO CD PLAYER Ⓞ IN OFFICE. SPEAKERS & Ⓞ PLAYER BY EXHIBITION DESIGNERS, WIRING BY ELEC. SUBCONTRACTOR.



Scale 1:50	Drawn RCF	Date MAY/00	Checked
---------------	--------------	----------------	---------

Allen Tod 
 Chartered Architects
 The Studio 32 The Calls Leeds LS2 7EW

REV A - POWER OUTLETS SHOWN IN EXHIB. AREA & OFFICE
 23 MAY/00
 RCF

Job No 98073.	Drawing No 506	Revision A
------------------	-------------------	---------------