


Amendments/Additional Information

- Amended layout of buildings/outside areas
- Additional background information
- Amended design
- Revised access arrangements
- Change of description of proposed development
- Change in site boundaries
- Other (as specified below)



Site Plan
Scale 1:2500

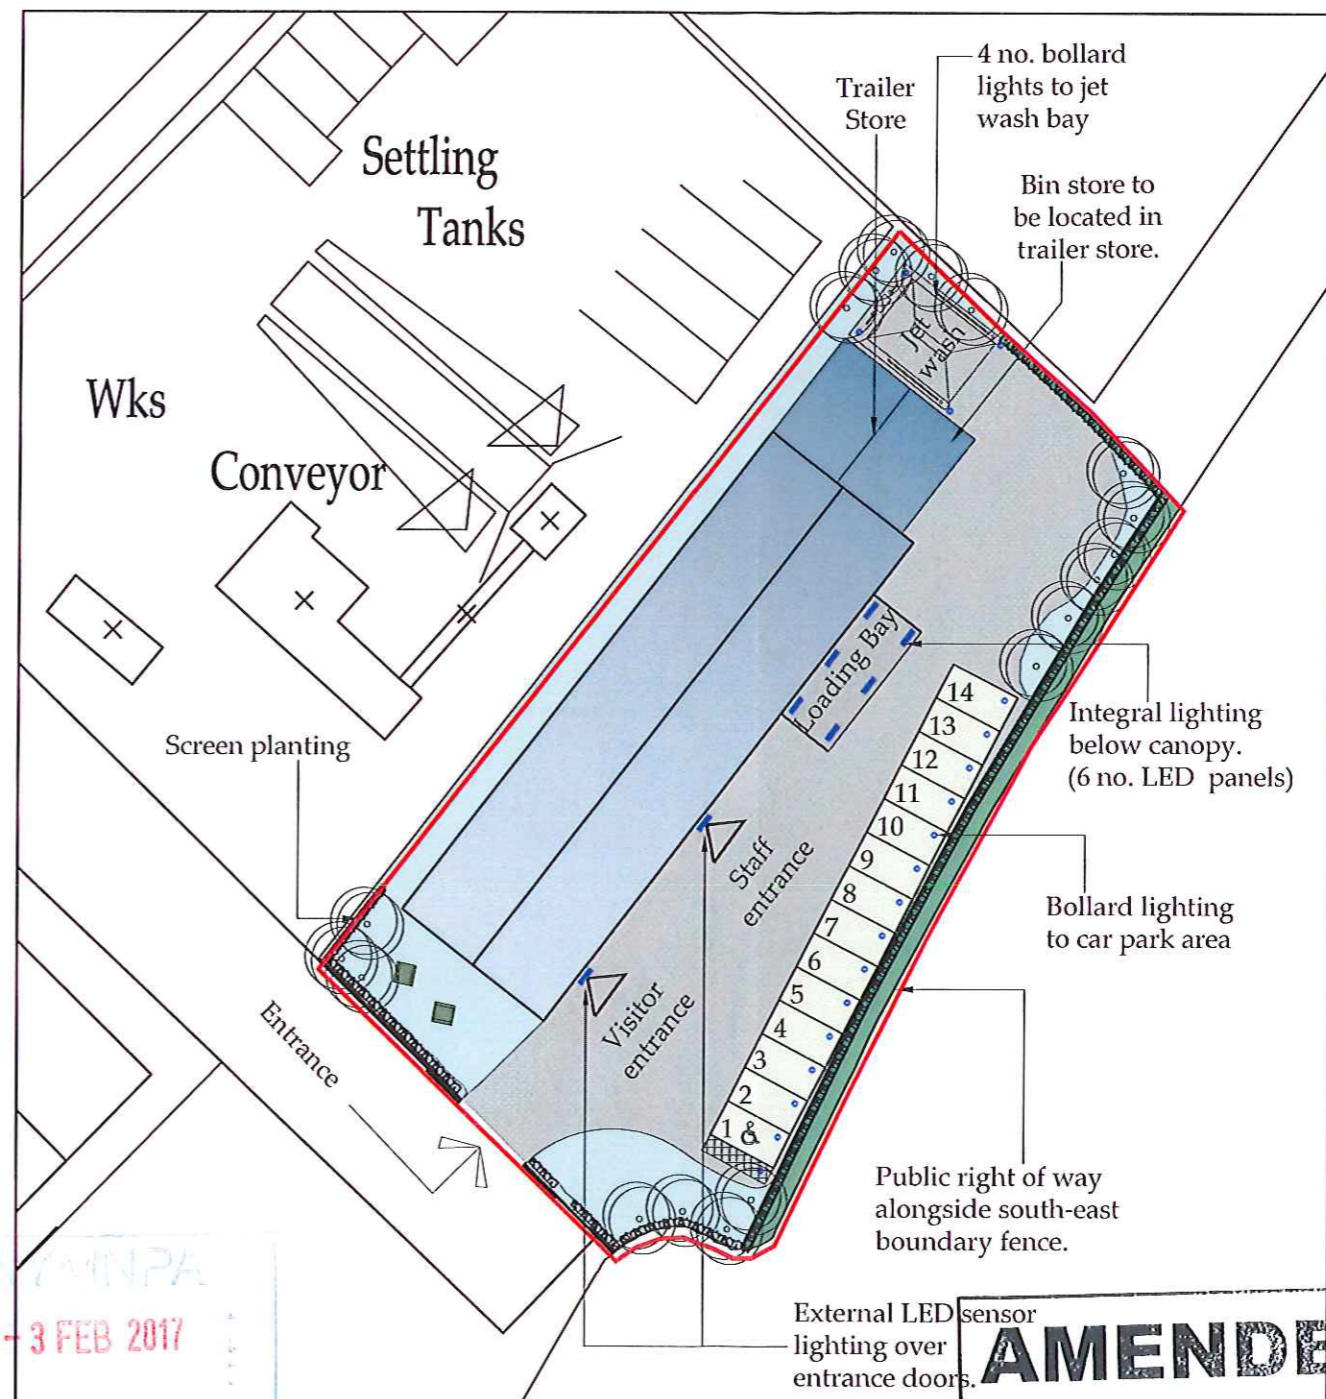

Block Plan
Scale 1:500

MANPA
- 3 FEB 2017

AMENDED

Notes

Ordnance Survey Licence No. 100002562

b h d partnership
Airy Hill Manor, Whitby, North Yorkshire, UK. YO21 1OB.
www.bhdpartnership.com

DO NOT SCALE from this drawing. Only figured dimensions are to be taken from this drawing.
The Contractor must verify all dimensions on site before commencing any work or shop drawings.
The Contractor must report any discrepancies before commencing work. If this drawing exceeds the quantities taken in any way, the Technician is to be informed before work is initiated.
Work within The Construction (Design and Management) Regulations 2015 is not to start until a Health & Safety Plan has been produced. This drawing is Copyright and must not be reproduced without consent of BHD Partnership Ltd

REV	DATE	BY	AMENDMENT	CHKD	APVD
B	03.02.17	CW	Red line amended to suit Solicitors in accord with Land Registry Plan	TRH	
A	04.01.17	CW	Issued for approval	TRH	

CLIENT:
Fusco's of Whitby

PROJECT:
Proposed offices & business premises, Whitby Business Park

A3 DRN: C. Walker DATE: 17.08.16
SCALE: As shown ISSUE: Tender


DRAWING TITLE:
Proposed Site and Block Plan Lighting Plan

DRAWING NR:
D11039-06

REV:
B



Site Plan
Scale 1:2500

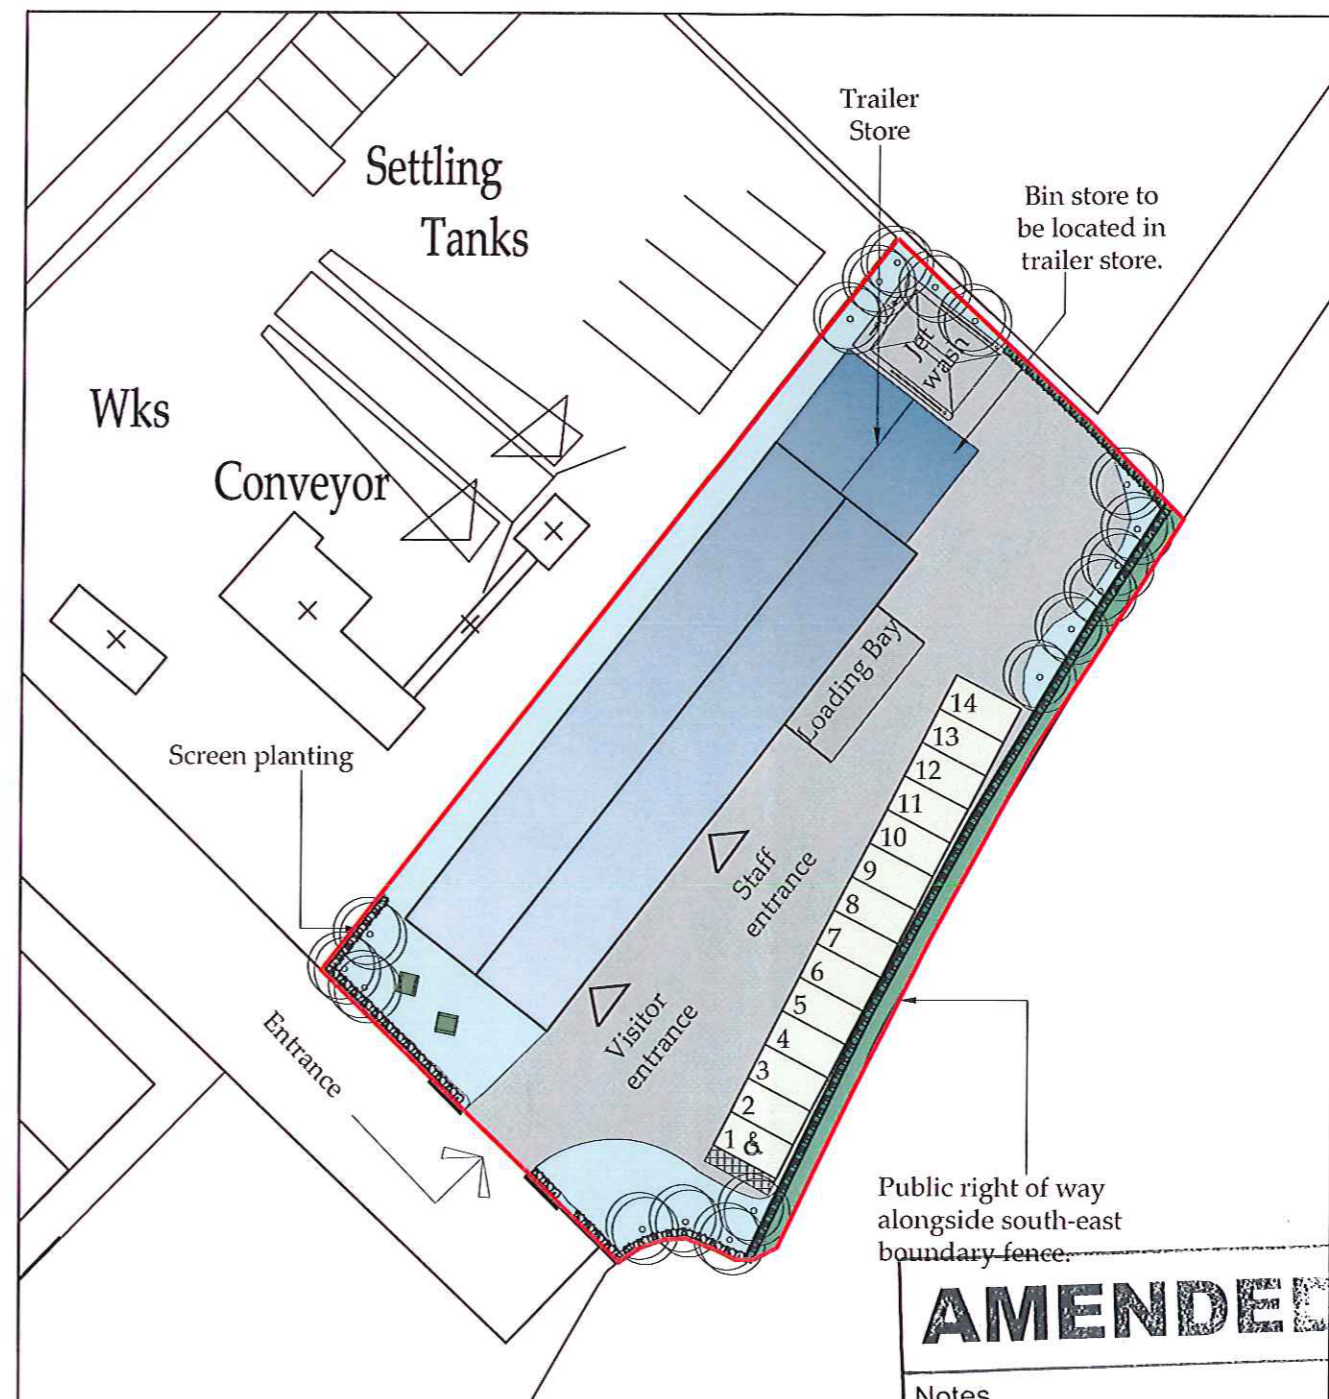

Block Plan
Scale 1:500

AMENDED

Notes

NYVALIPA
-3 FEB 2017

Ordnance Survey Licence No. 100002562

b h d partnership
Airy Hill Manor, Whitby, North Yorkshire, UK. YO21 1OB.
www.bhdpartnership.com

● DO NOT SCALE from this drawing. Only figured dimensions are to be taken from this drawing.
● The Contractor must verify all dimensions on site before commencing any work or shop drawings.
The Contractor must report any discrepancies before commencing work. If this drawing exceeds the quantities taken in any way, the Technician is to be informed before work is initiated.
Work within The Construction (Design and Management) Regulations 2015 is not to start until a Health & Safety Plan has been produced. This drawing is Copyright and must not be reproduced without consent of BHD Partnership Ltd

REV	DATE	BY	AMENDMENT	CHKD	APVD
D	03.02.17	CW	Red line amended to suit Solicitors in accord with Land Registry Plan	TRH	
C	21.11.16	CW	Notes added	TRH	
B	26.10.16	CW	Amended to suit client comments.	TRH	
A	18.08.16	CW	Issued for approval	TRH	

CLIENT:
Fusco's of Whitby

PROJECT:
Proposed offices & business premises, Whitby Business Park

A3 DRN: C. Walker DATE: 17.08.16
SCALE: As shown ISSUE: Tender

DRAWING TITLE:
Proposed Site and Block Plan

DRAWING NR:
D11039-01

REV:
D