

NYMNP  
- 8 JUL 2011



5	28.03.11	07.03.11 COMMENTS INCORPORATED, CIRCUITS AVENDED TO FUNCTION ROOM.
4	01.03.11	LIGHTING IN POOL AREA, WC'S, CHANGING ROOMS, GYM & FUNCTION BAR REVISED.
3	17.02.11	SWITCHES ADDED FOR 5A SKITS IN SUITES. 5A SKITS ADDED TO TREATMENT ROOMS. LIFT LOBBY FITTING TYPES CHANGED. FUNCTION BAR LIGHTING REVISED. CHANGING WC FITTING TYPE CHANGED. SPOTS ADDED OVER SINKS IN WC'S. TREATMENT ROOM CORRIDOR REVISED. FUNCTION ROOM LTG REVISED.
2	31.01.11	SPA TREATMENT ROOM LAYOUTS REVISED.
1	18.01.11	EXTERNAL LTG CIRCUITS ADDED. GYM LIGHTING REVISED. LIGHTING TO SUITES REVISED.
E	17.12.10	COMMENTS FROM SL INCORPORATED
D	18.10.10	SWITCHING/CONTROLS ADDED.
C	11.05.10	COMMENTS FROM SL INCORPORATED
B	28.04.10	BUILDING LAYOUT UPDATED
A	26.03.10	COMMENT FROM SL INCORPORATED
Rev	Date	Revisions

**MORFITTS**  
BUILDING SERVICES  
ENGINEERS

Tel: 0113 3970500  
Fax: 0113 3970555  
www.morfitts.co.uk

4 Cotton Mill  
Bullthorpe Lane  
Leeds LS15 9JN

Client Project:  
**Raithwaite Hall  
Hotel, Whitby**

Drawing Title:  
**Lower ground floor  
Lighting layout**


Drawn: SW	Chkd: SW	Status: <b>Construction</b>
Scale @ A1: 1:100	Date: March 2010	

Draw No:  
**10139/E12**

Rev: **5**

THIS DRAWING IS THE PROPERTY OF MORFITTS & SHOULD NOT BE REPRODUCED IN WHOLE OR PART WITHOUT WRITTEN AUTHORITY.



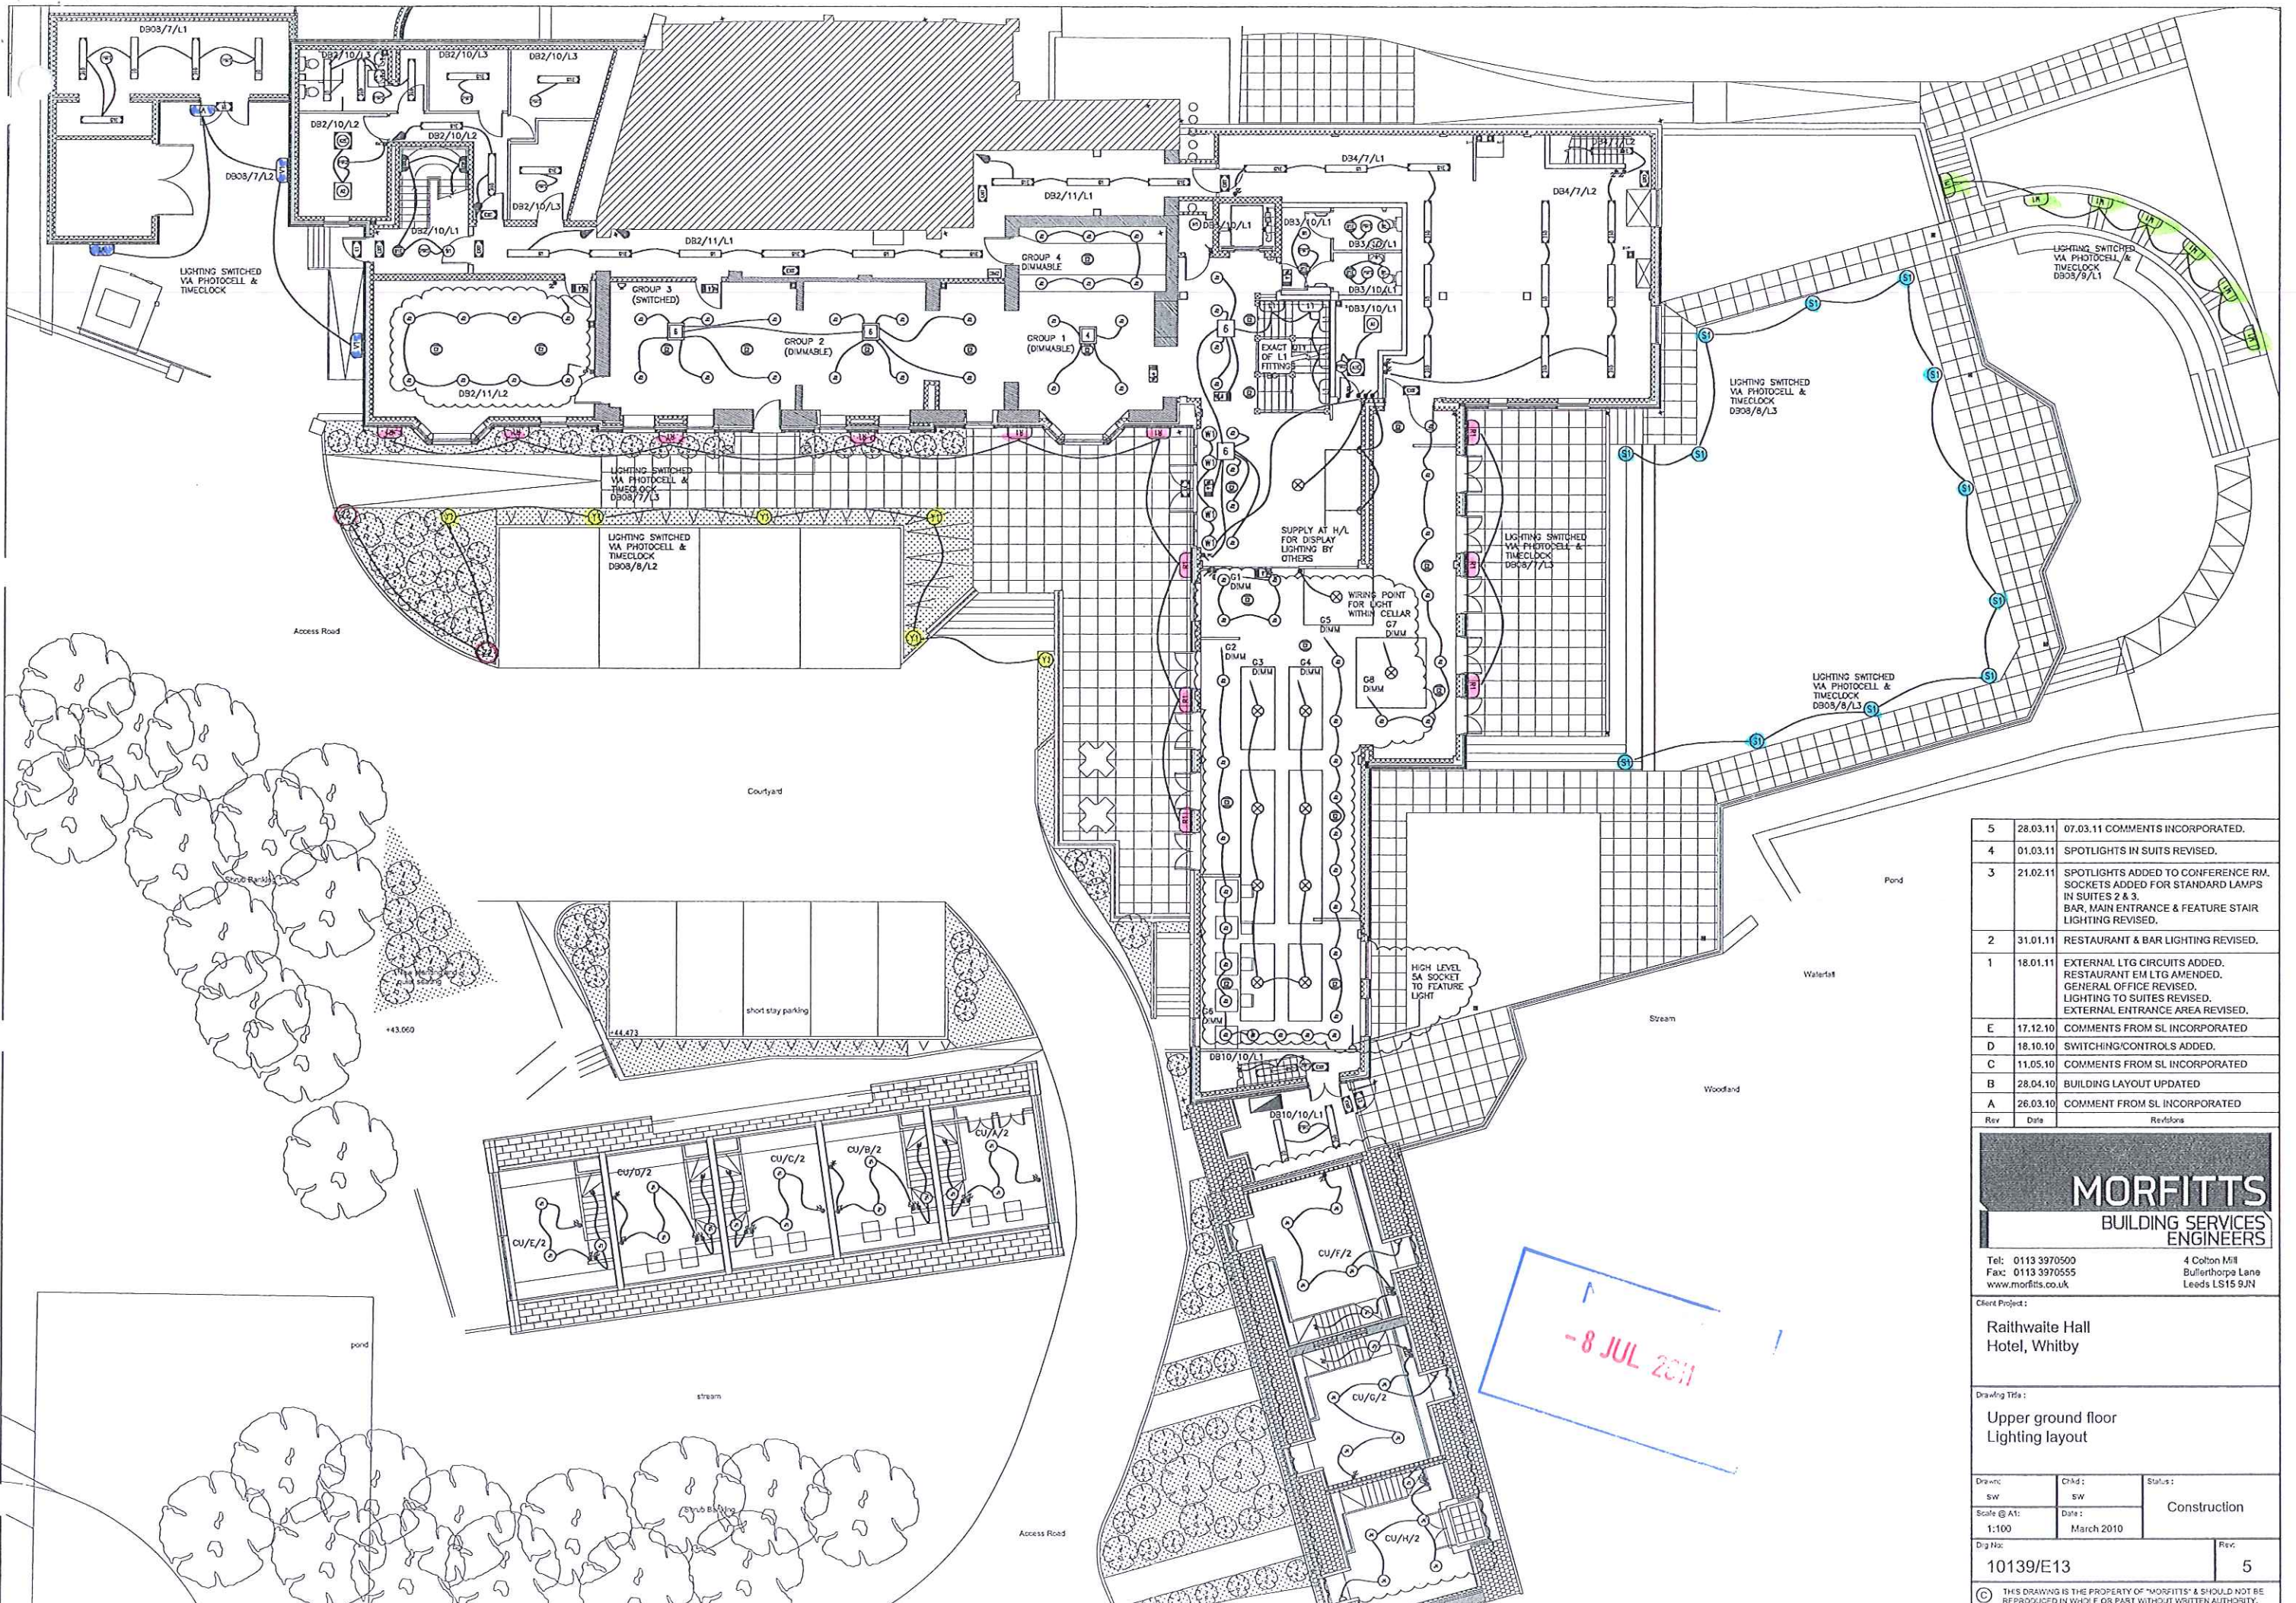

Rev	Date	Revisions
5	28.03.11	07.03.11 COMMENTS INCORPORATED.
4	01.03.11	SPOTLIGHTS IN SUITS REVISED.
3	21.02.11	SPOTLIGHTS ADDED TO CONFERENCE RM. SOCKETS ADDED FOR STANDARD LAMPS IN SUITES 2 & 3. BAR, MAIN ENTRANCE & FEATURE STAIR LIGHTING REVISED.
2	31.01.11	RESTAURANT & BAR LIGHTING REVISED.
1	18.01.11	EXTERNAL LTG CIRCUITS ADDED. RESTAURANT EM LTG AMENDED. GENERAL OFFICE REVISED. LIGHTING TO SUITES REVISED. EXTERNAL ENTRANCE AREA REVISED.
E	17.12.10	COMMENTS FROM SL INCORPORATED
D	18.10.10	SWITCHING/CONTROLS ADDED.
C	11.05.10	COMMENTS FROM SL INCORPORATED
B	28.04.10	BUILDING LAYOUT UPDATED
A	26.03.10	COMMENT FROM SL INCORPORATED

**MORFITTS**  
BUILDING SERVICES ENGINEERS

Tel: 0113 3970500  
Fax: 0113 3970555  
www.morfitts.co.uk

4 Colton Mill  
Bullerthorpe Lane  
Leeds LS15 9JN


Client Project:  
**Raithwaite Hall Hotel, Whitby**

Drawing Title:  
**Upper ground floor Lighting layout**

Drawn: SW	Crtd: SW	Status: <b>Construction</b>
Scale @ A1: 1:100	Date: March 2010	Rev: <b>5</b>
Dig No: <b>10139/E13</b>		

THIS DRAWING IS THE PROPERTY OF "MORFITTS" & SHOULD NOT BE REPRODUCED IN WHOLE OR PART WITHOUT WRITTEN AUTHORITY.



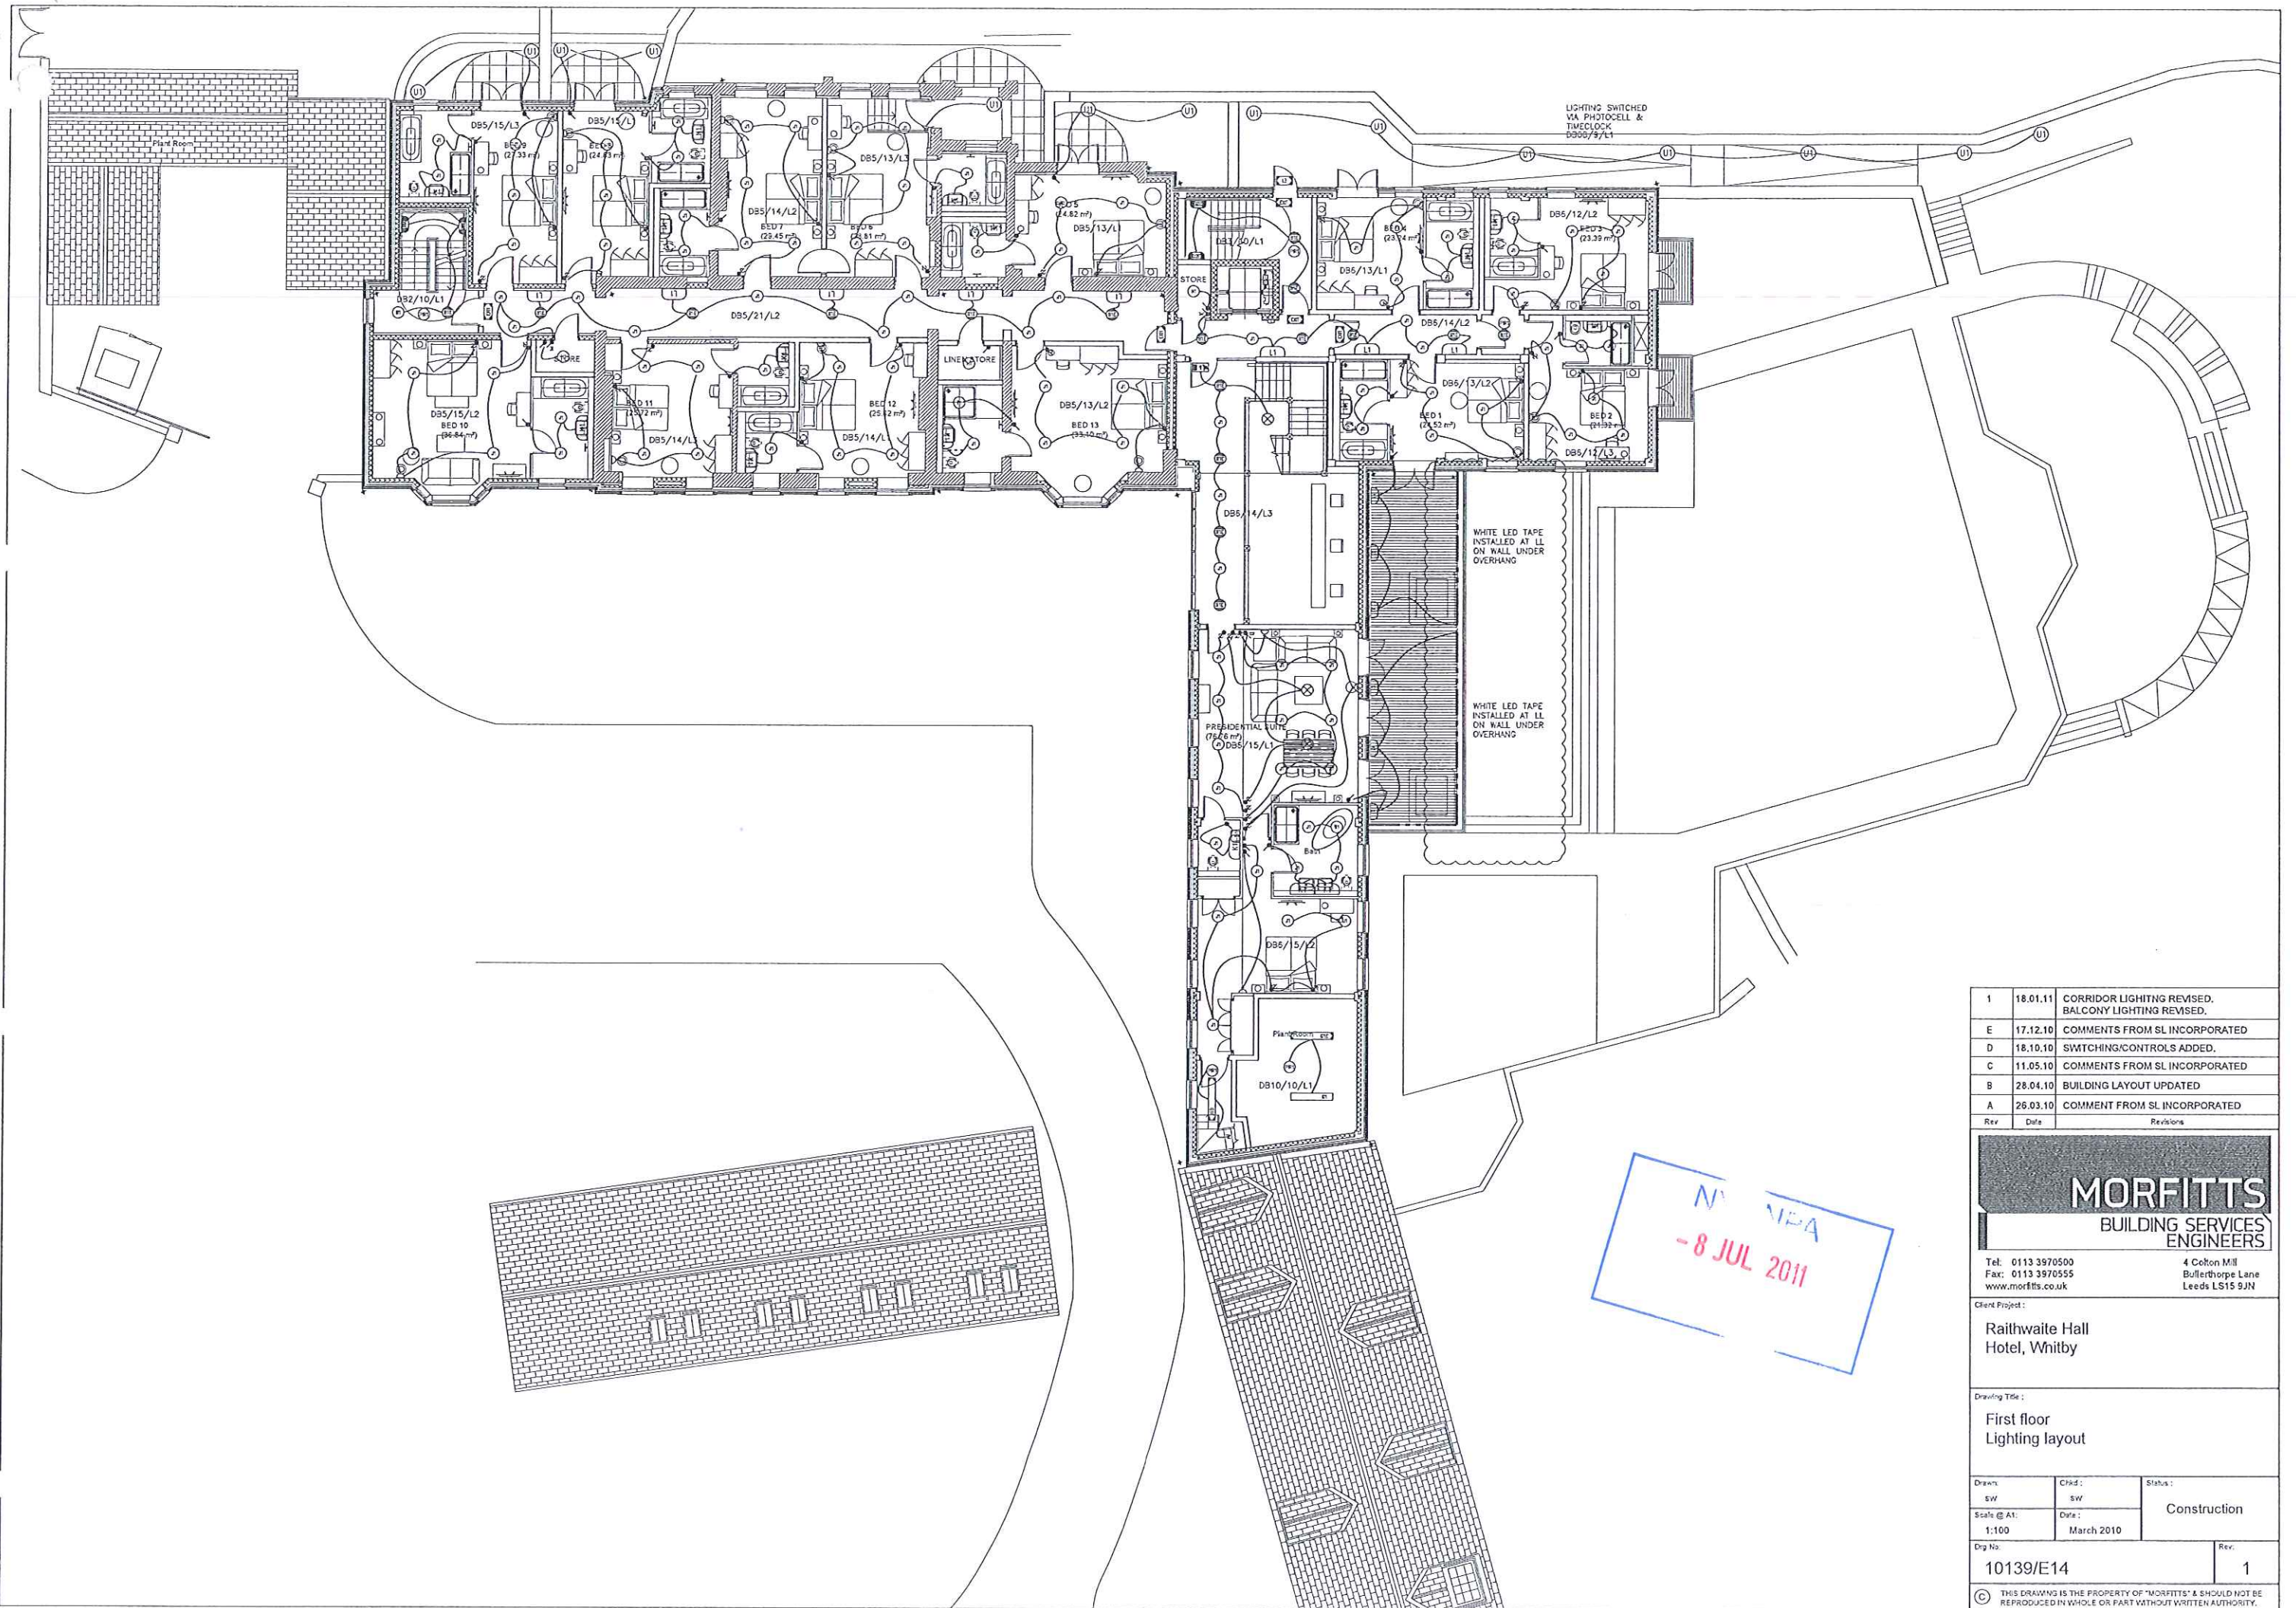

Rev	Date	Revisions
1	18.01.11	CORRIDOR LIGHTING REVISED. BALCONY LIGHTING REVISED.
E	17.12.10	COMMENTS FROM SL INCORPORATED
D	18.10.10	SWITCHING/CONTROLS ADDED.
C	11.05.10	COMMENTS FROM SL INCORPORATED
B	28.04.10	BUILDING LAYOUT UPDATED
A	26.03.10	COMMENT FROM SL INCORPORATED

**MORFITTS**  
BUILDING SERVICES  
ENGINEERS

Tel: 0113 3970500  
Fax: 0113 3970555  
www.morfitts.co.uk

4 Colton Mill  
Butterthorpe Lane  
Leeds LS15 9JN

Client Project:  
**Raithwaite Hall  
Hotel, Whitby**

Drawing Title:  
**First floor  
Lighting layout**

Drawn: SW	Check: SW	Status: <b>Construction</b>
Scale @ A1: 1:100	Date: March 2010	

Dwg No: **10139/E14** Rev: **1**

© THIS DRAWING IS THE PROPERTY OF "MORFITTS" & SHOULD NOT BE REPRODUCED IN WHOLE OR PART WITHOUT WRITTEN AUTHORITY.