



SCALE 1:100

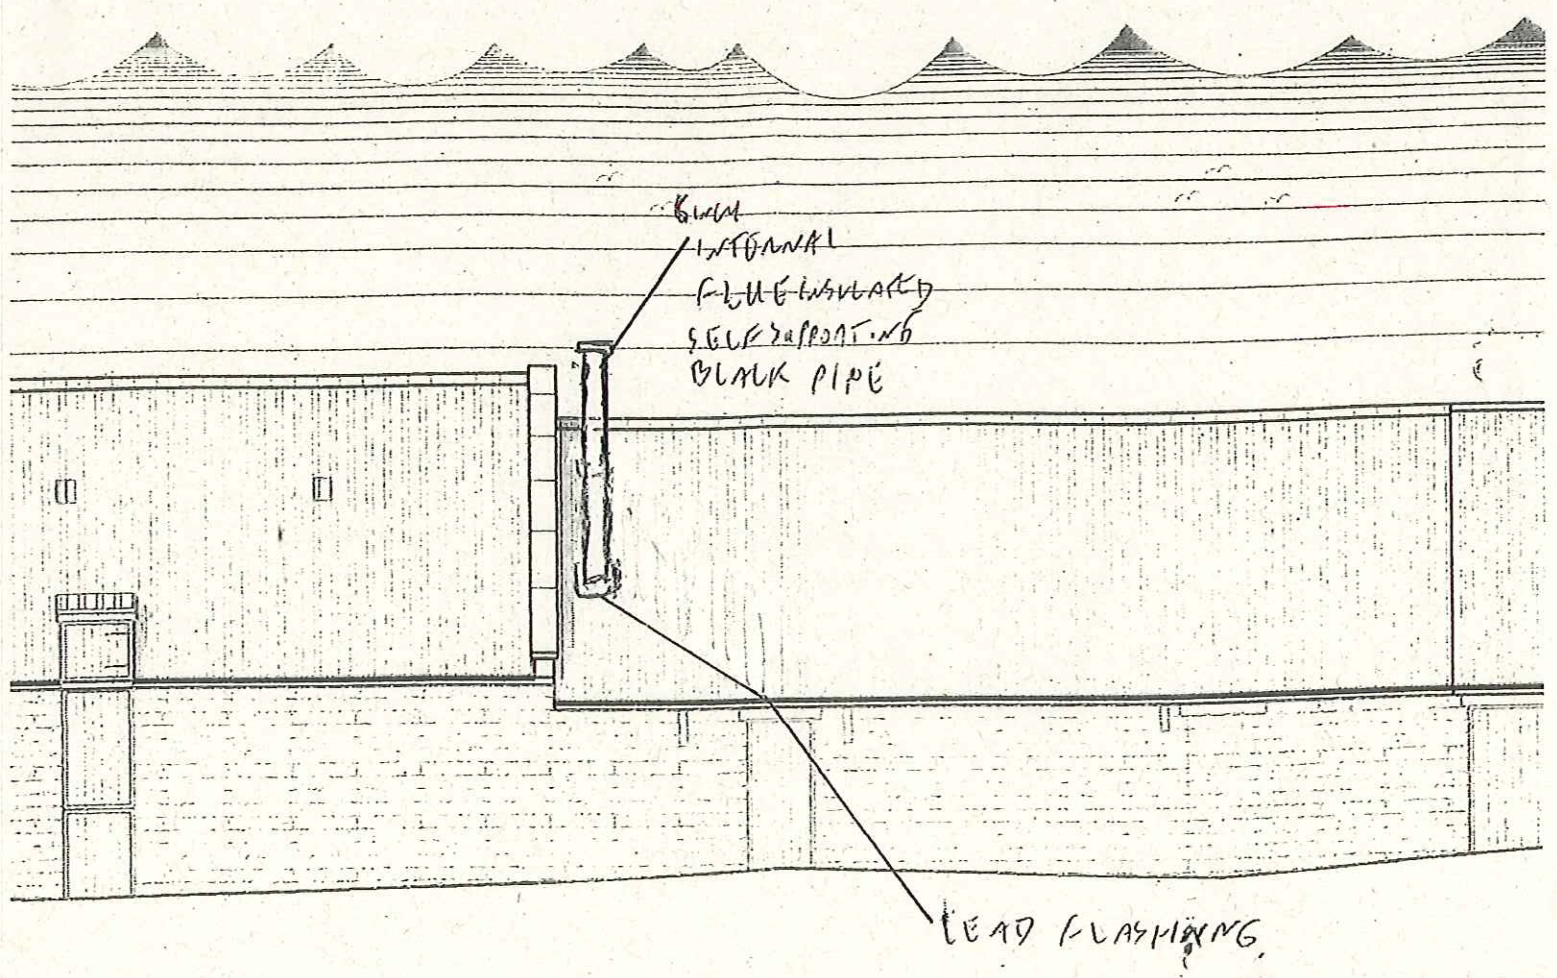

CURRENT CHIMNEY REAR ELEVATION

NYMNPA
09 MAY 2014

SCALE 1:100

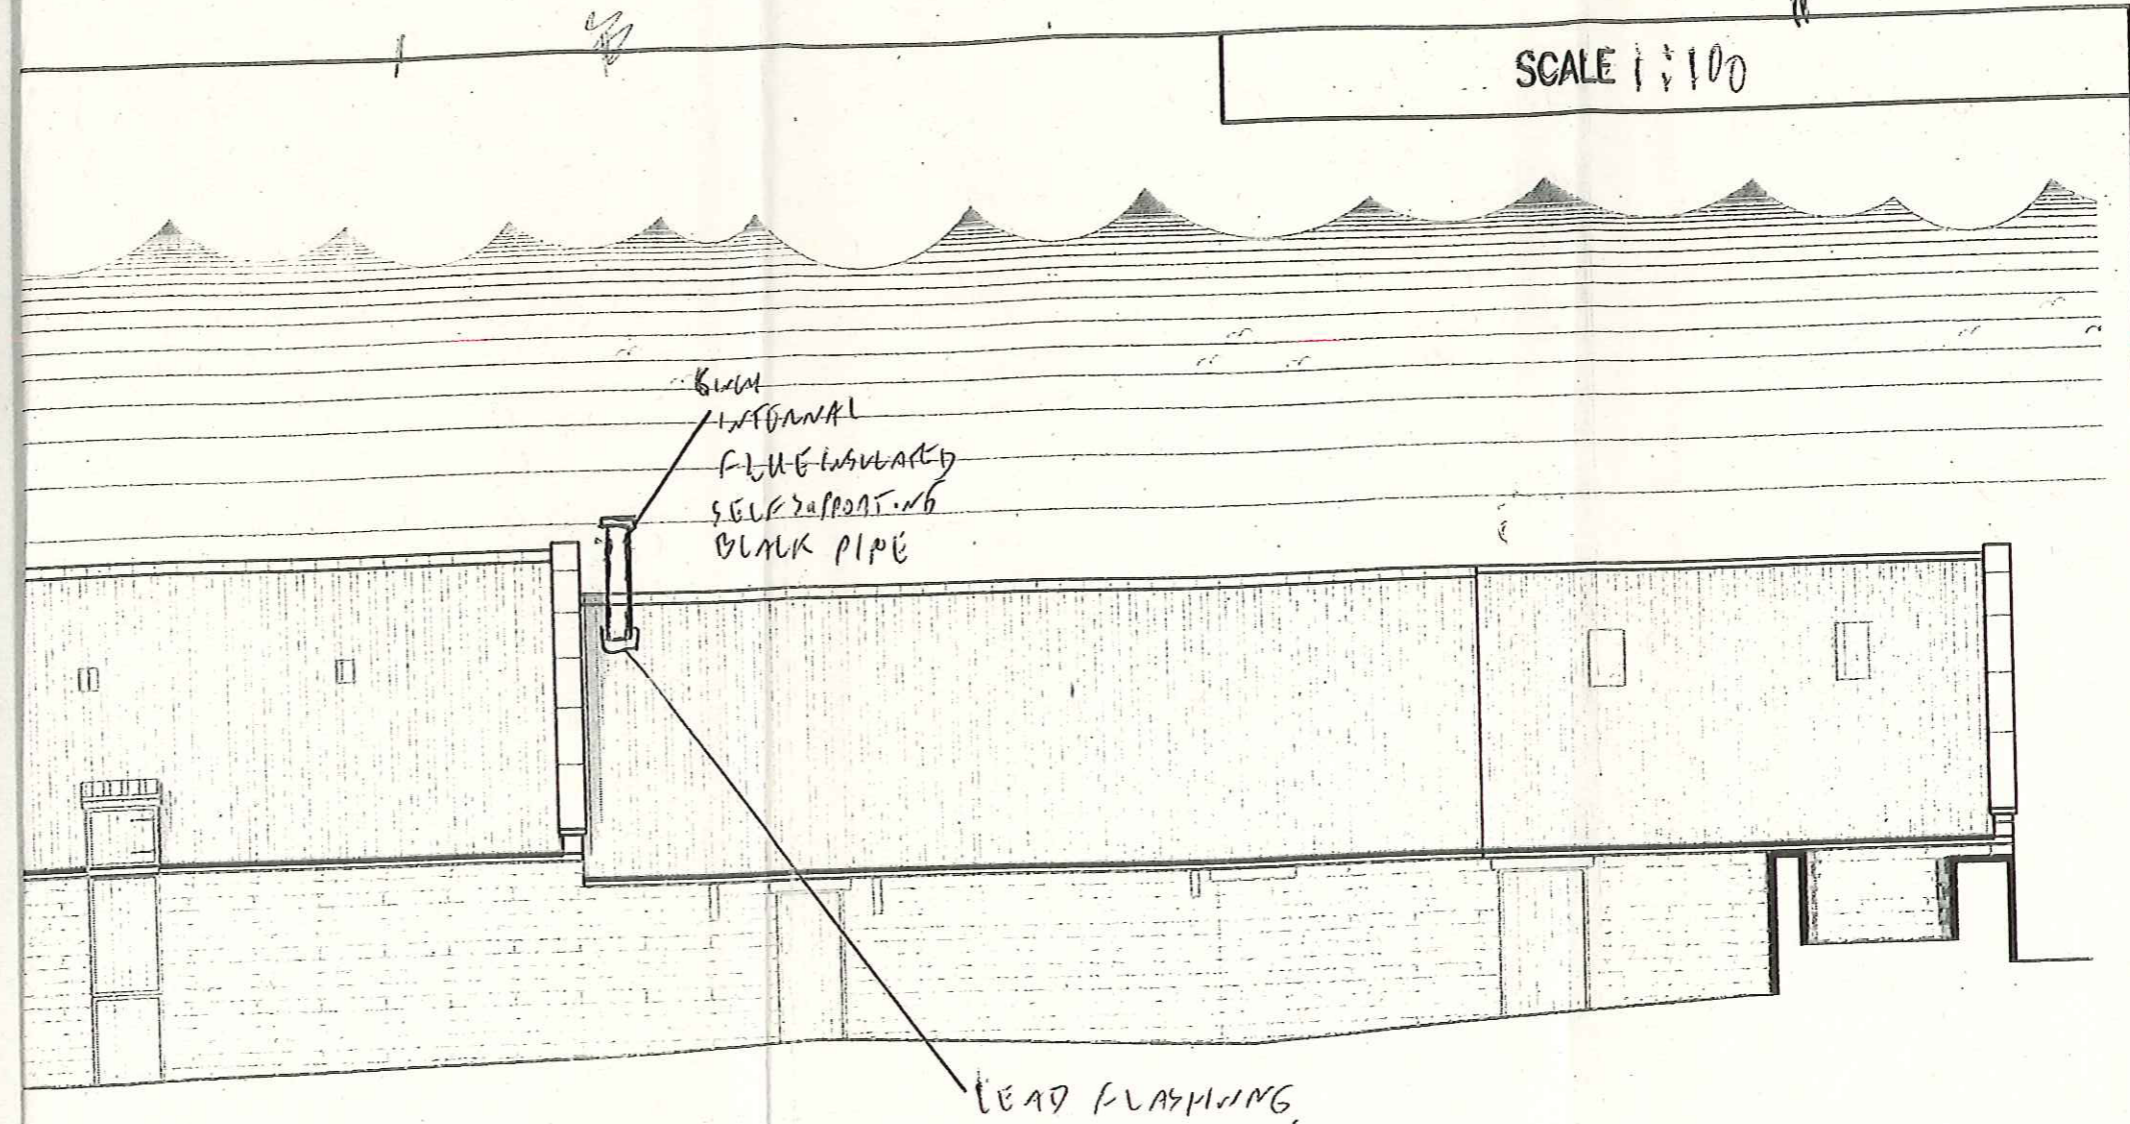

CHIMNEY
REAR ELEVATION

Proposed

NYMNPDA
09 MAY 2014

SCALE 1:100

SHOW
INTERNAL
FLUE INSULATION
SELF-SUPPORTING
BLACK PIPE

LEAD FLASHING

Extent of the concrete

CHIMNEY
REAR ELEVATION

NYMNP
07 APR 2014

